


© Date: _____
Signed: _____

| revised: | date: | description: |
|----------|-------|--------------|
| | | |
| | | |
| | | |
| | | |
| | | |


SassCo Engineering Inc.
Consulting & Design



274 Barwind Road Wayne PA 19087
TEL: 610 975 1000 610 217 6000
FAX: 610 975 1000 610 240 6000

CAROTA LANDSCAPING

449 E. CHURCH ROAD
KING OF PRUSSIA, PA 19406

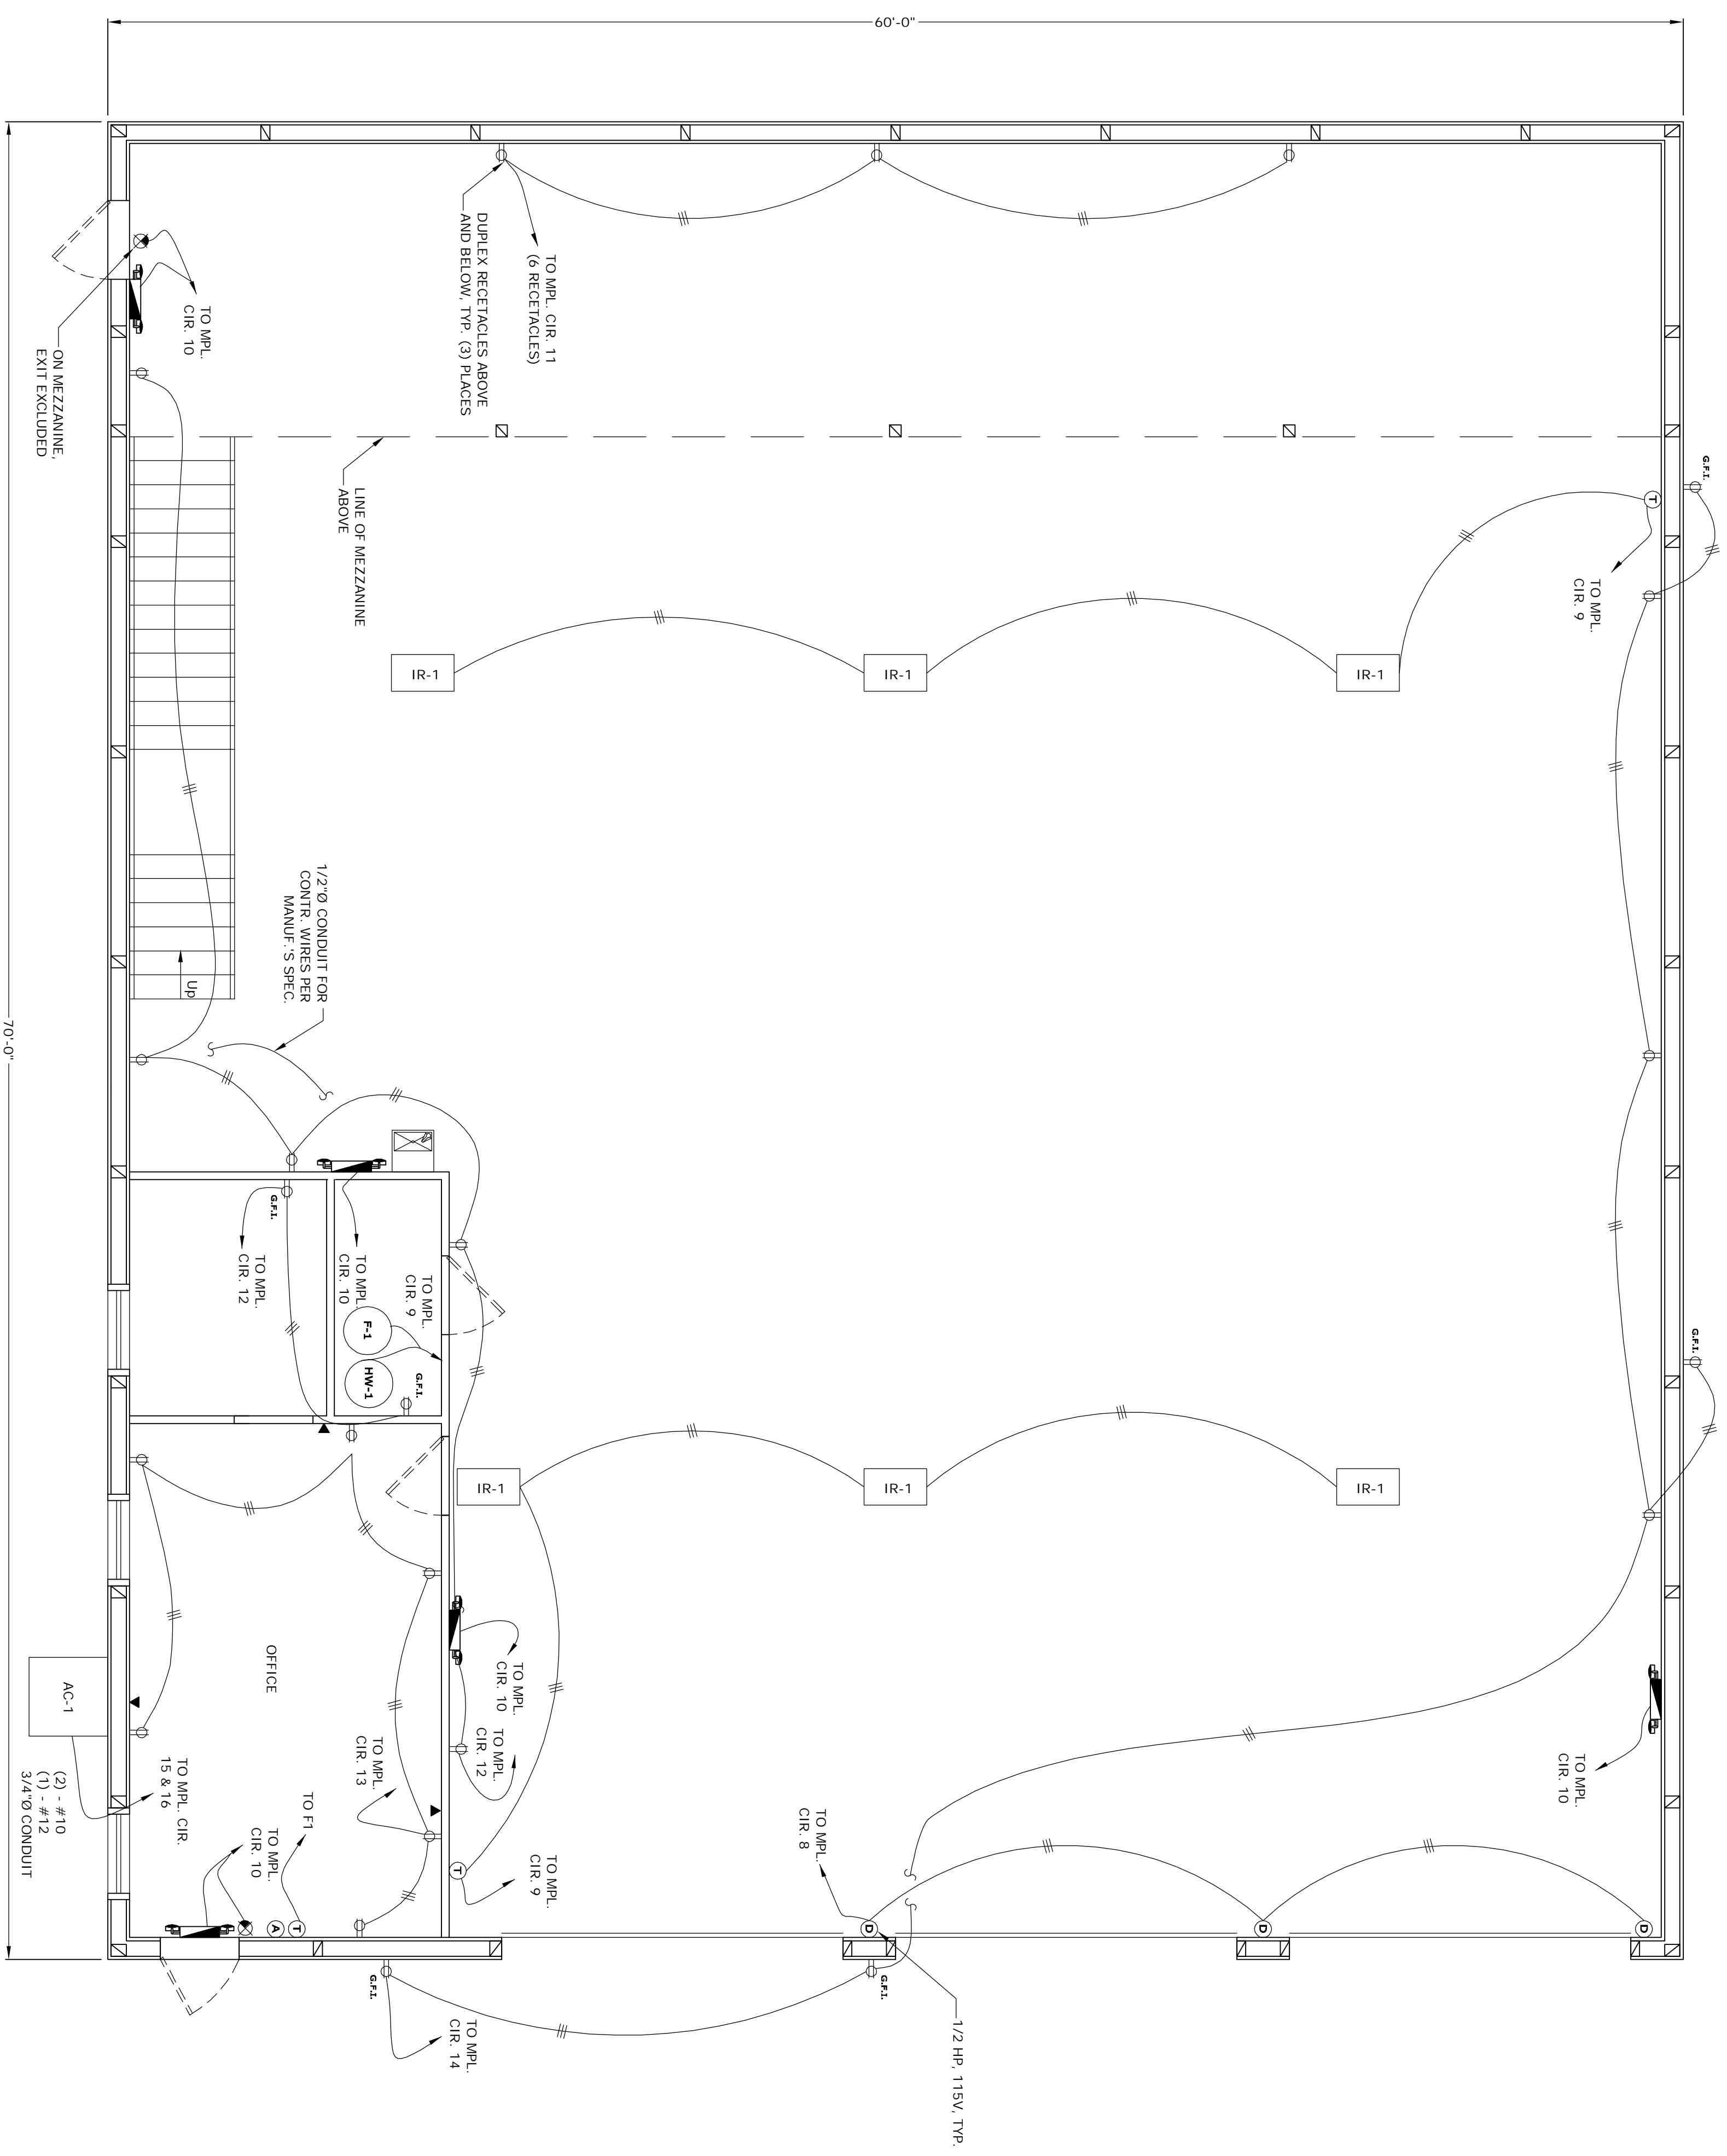

ELECTRICAL LEGEND

- DUPLEX RECEPTACLE - HEAVY DUTY
- GROUND FAULT RECEPTACLE - HEAVY DUTY
- WALL OUTLET FOR TELEPHONE WIRING, STUB UP EMPTY
- 3/4" C. TO CEILING SPACE
- SINGLE POLE SWITCH
- 2-WAY SWITCH
- BASEBOARD HEATER
- SURFACE OR RECESSED BATTERY OPERATED EMERGENCY LIGHT OR BATTERY SYSTEM - SEE DRAWINGS FOR TYPE
- GARAGE DOOR CONTROL'S LIFTMASTER MODEL J5011
- JUNCTION BOX AS NOTED
- CONDUIT CONCEALED IN CEILING OR WALL
- THREE WIRE W/ BX CONDUIT
- CONDUIT CONCEALED IN FLOOR
- BURGULAR ALARM OUTLET AS NOTED
- THERMOSTAT
- ILLUMINATED EXIT SIGN

MAIN PANEL (MPL)

SQUARE D NCOO PANEL BOARD 225 AMP 208/120 VOLT 30 POSITION

| | | |
|-------|-----|--|
| 1 | 20A | OH LIGHTS 1st BAY |
| 2 | 20A | OH LIGHTS 2nd BAY |
| 3 | 20A | OH LIGHTS 3rd BAY |
| 4 | 20A | OH LIGHTS 4th BAY |
| 5 | 20A | MEZZANINE |
| 6 | 20A | OUTSIDE LIGHTS & TIMER |
| 7 | 20A | OH LIGHTS OFFICE, TOILET & UTILITY ROOMS |
| 8 | 20A | OH LIGHTS |
| 9 | 20A | (3) DR BOOKS |
| 10 | 20A | HW HEATER |
| 11 | 20A | EMERGENCY & EXIT LIGHTS |
| 12 | 20A | RECEPTACLES - MEZZANINE & BACK WALL |
| 13 | 20A | RECEPTACLES - STAIRWAY & EXTERIOR OFFICE WALLS |
| 14 | 20A | RECEPTACLES - STAIRWAY & EXTERIOR OFFICE WALLS |
| 15/16 | 30A | A/C COMPRESSOR W/ COMMON TRIP |

PANEL SCHEDULE

| 225A MAIN CB | 225A MAIN CB |
|--------------|--------------|
| 20A #1 | #9 20A |
| 20A #2 | #10 20A |
| 20A #3 | #11 20A |
| 20A #4 | #12 20A |
| 20A #5 | #13 20A |
| 20A #6 | #14 20A |
| 20A #7 | #15 30A |
| 20A #8 | #16 30A |

job number: _____
sheet no: SRH
designed by: _____
date: 10 JUL 2009
scale: AS SHOWN
POWER FLOOR PLAN & SCHEDULES