

SassCo Engineering Inc.
Consulting & Design
274 Barwind Road
Wayne, PA 19087
TEL: 610 995 2176
FAX: 610 971 2406

 

 



MUSIC TRAINING CENTER
MONTGOMERYVILLE
AIRPORT SQUARE SHOPPING CENTER
801 BETHLEHEM PIKE, UNIT #6
NORTH WALES, PA 19454

job number:
SAS
drawn by:
SRH
checked by:
date:
30 SEPT 09
scale:
AS SHOWN

MECHANICAL PLAN

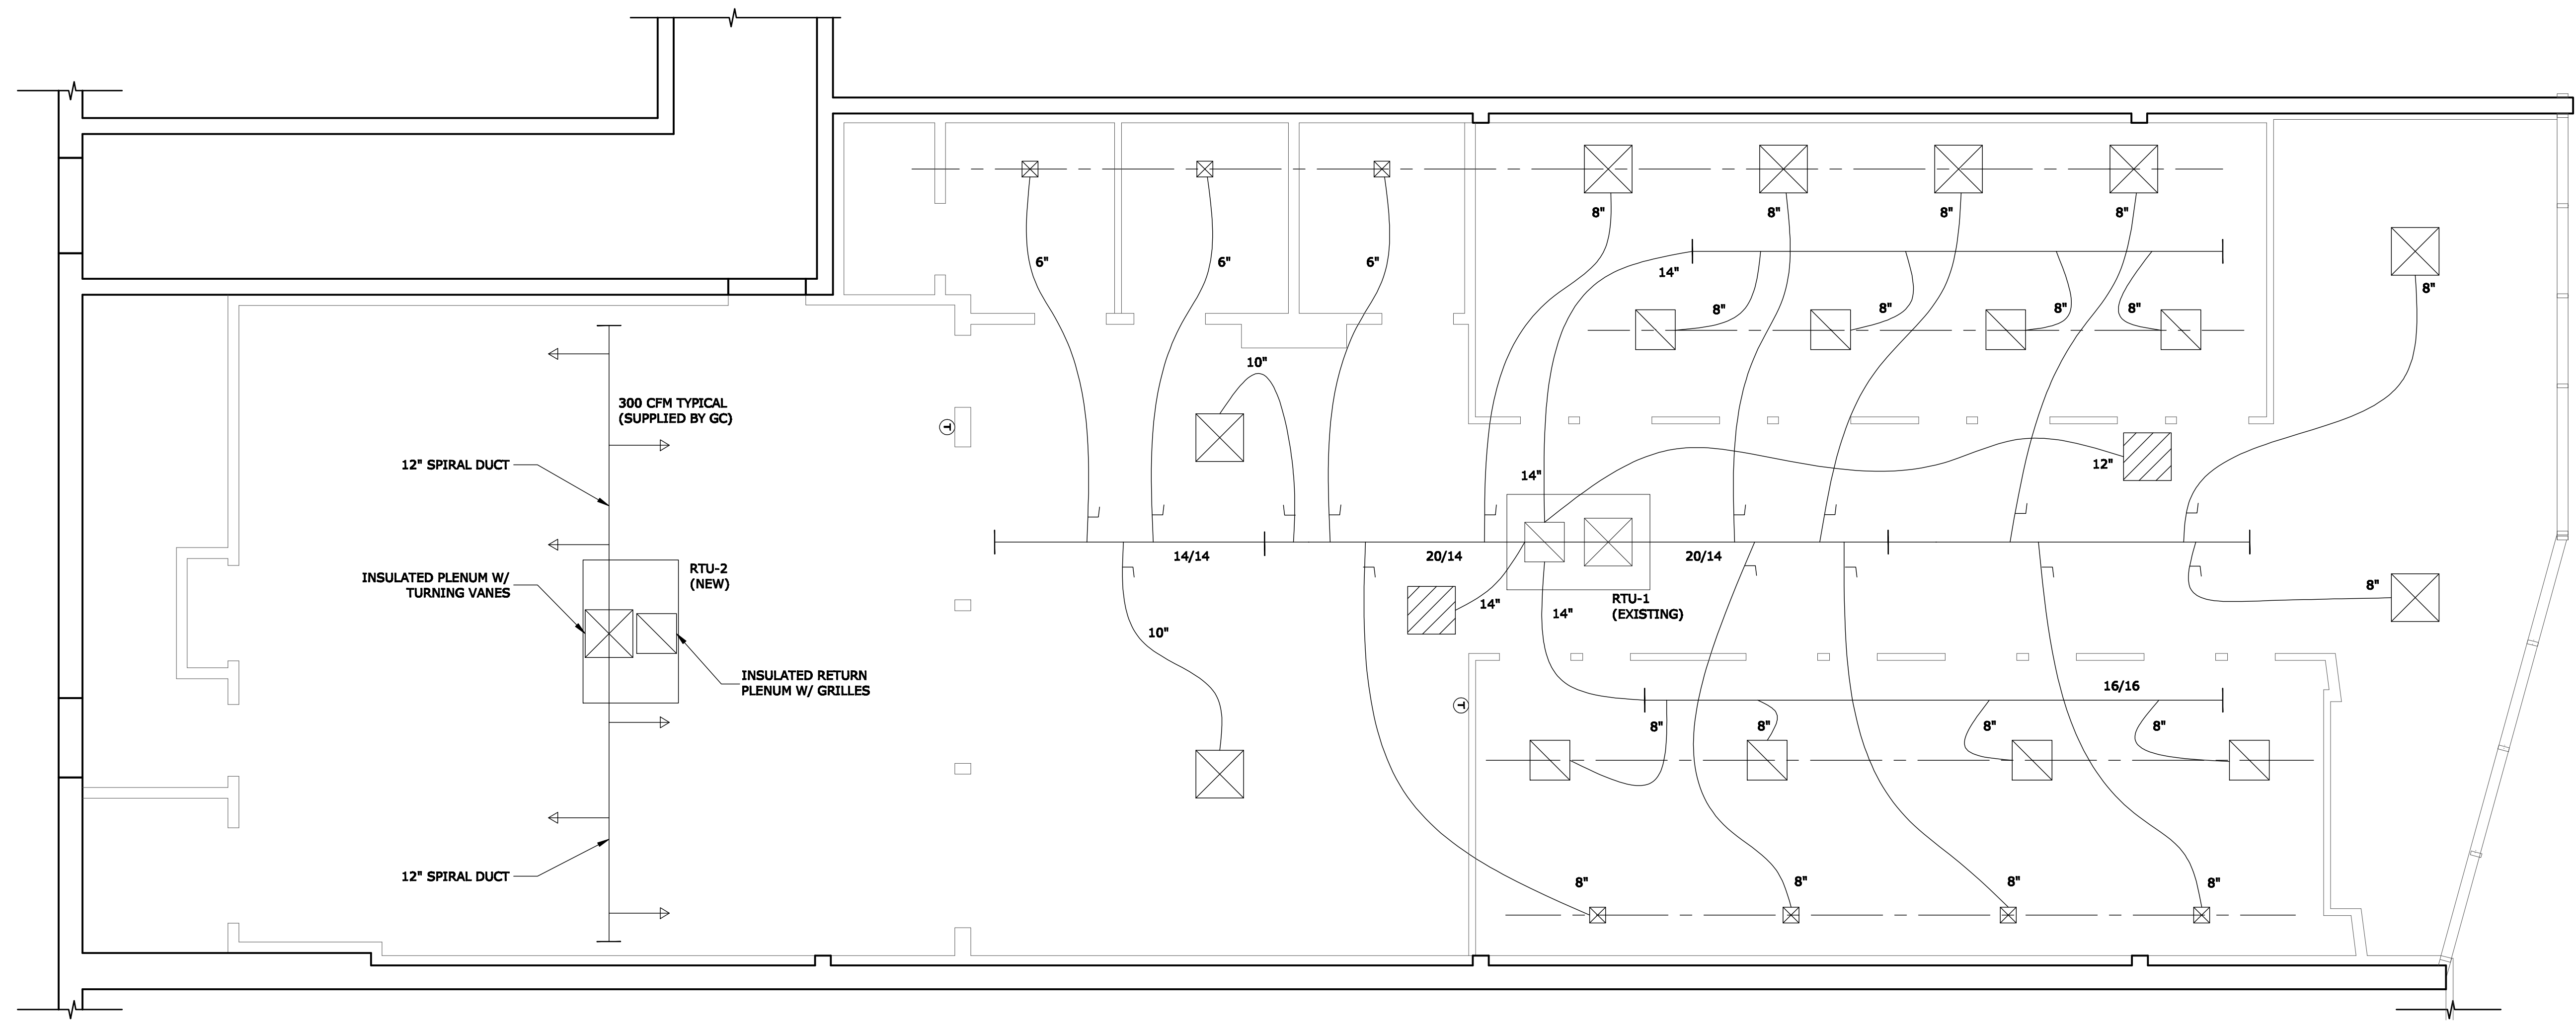
M-1

LEGEND

-  2'x2' T-BAR SUPPLY REGISTER
-  8'x8' SUPPLY REGISTER
-  20'x20' T-BAR RETURN GRILLE
-  2'x2' T-BAR RETURN GRILLE
-  VOLUME DAMPER
-  THERMOSTAT

ALL TRUNK DUCT TO BE INSULATED METAL
ALL BRANCH DUCT TO BE INSULATED FLEX

RTU-1: 10 TON CARRIER GAS/ELECTRIC (EXISTING)
RTU-2: 5 TON CARRIER 208/230 3 PHASE MODEL 48TME006 GAS/ELECTRIC (NEW)



MECHANICAL PLAN
1/4" = 1'-0"